


SETTLING PONDS
SITE PLAN
NTS

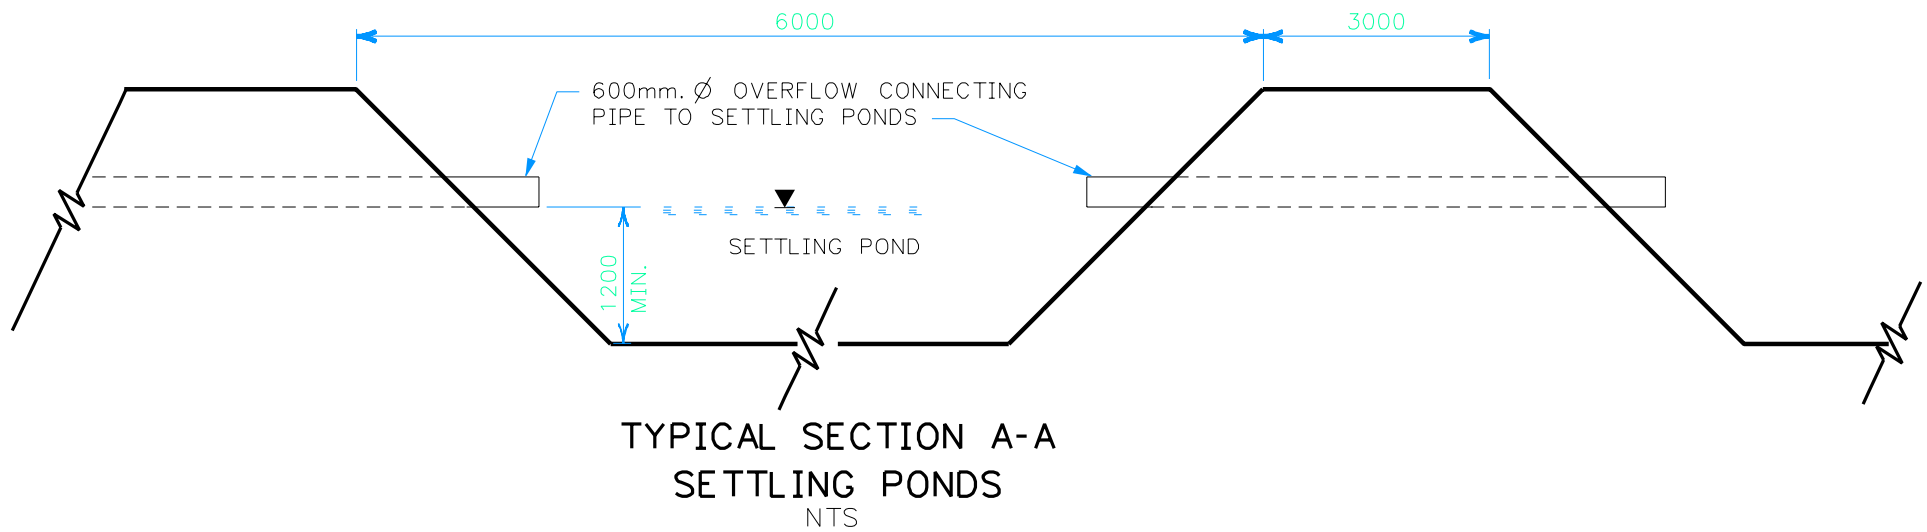

TYPICAL SECTION A-A
SETTLING PONDS
NTS

No.	Revision	Ckd. By	Date

RECORD DRAWING

	Const. North
	Drawn By: RJH
	Dwg. Standards Ckd. By: WGM
	Designed By:
Date Printed 05.NOV.24	Dwg. Design Ckd. By:

ADI Limited
St. John's, NF, Canada
Engineering, Consulting, Procurement and Project Management

Project Title ENVIRONMENTAL SERVICES PROPOSED QUARRY PIT DEVELOPMENT INCINERATOR ROAD AREA FOXTRAP, NL		
Dwg. Title PROPOSED SETTLING PONDS SITE PLAN		
Project No.	26-3971-013.1	
Dwg. No.	FIGURE 3	Rev. No.
Scale	NOT TO SCALE This drawing is not to be scaled	

Offices located in:
Charlottetown, Moncton, Saint John, Truro, Halifax, Sydney
Port Hawkesbury, St. John's, Fredericton and Salem, NH